

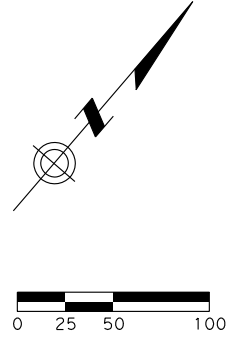
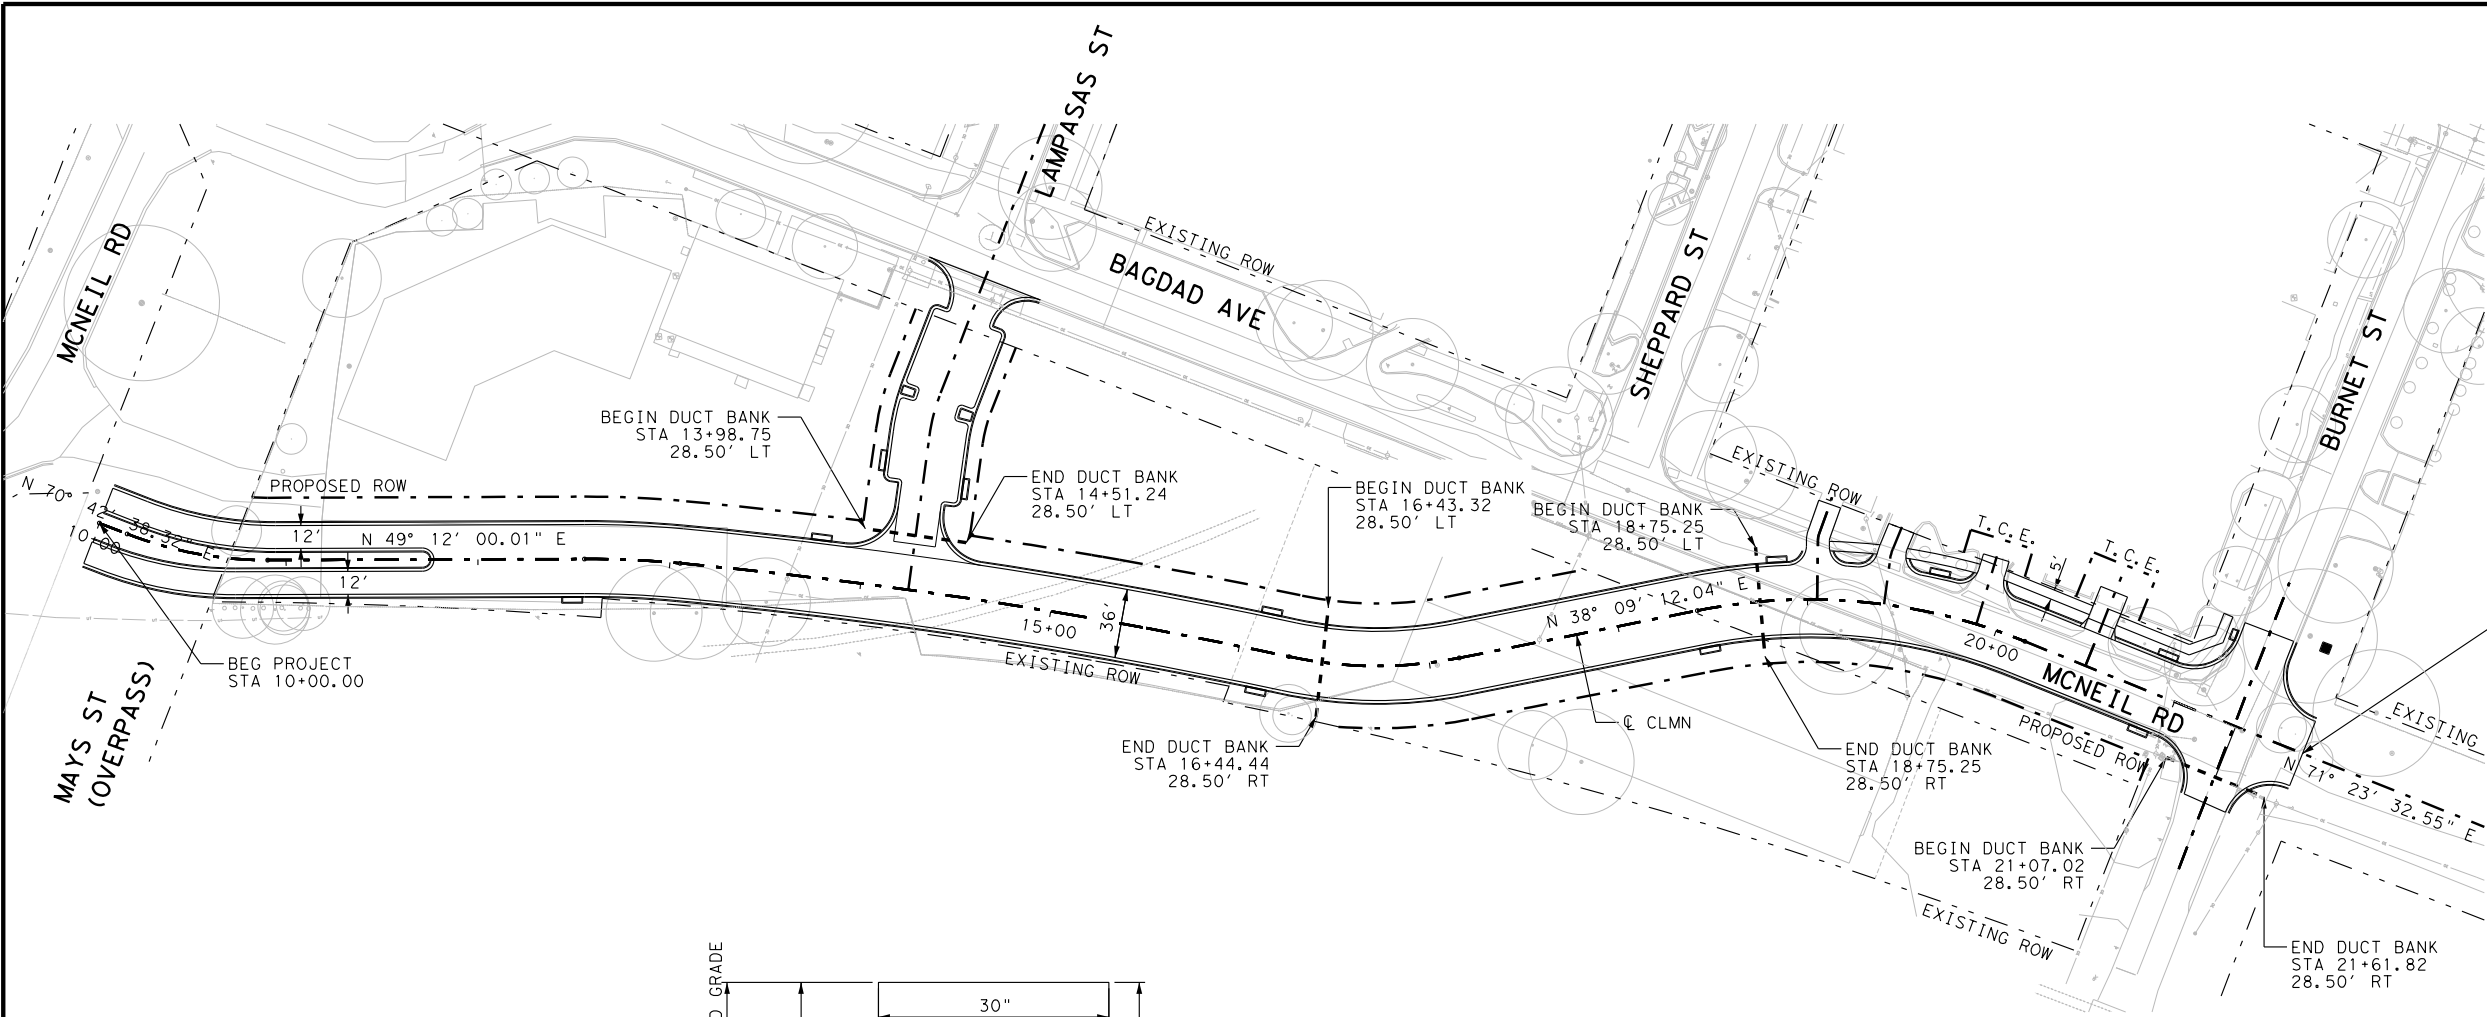


100% SUBMITTAL
DATE: 4/18/2018
TIME: 8:29:44 AM
PLOT DRIVER: \$PLTDRVL\$
PEN TABLE: MN_Texas\step_pentable_e.co.tbl
FILE: pw:\\CUSD036301.wsd\atkins.com\ATKATX01\Documents\Projects\100047508 McNeil Rd Extension\CADD\UTL\MN_RDWY_UTL_120C_DuctBank

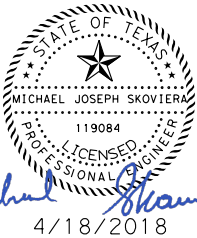

- NOTES:
1. REFER TO SHEETS 120B AND 126 FOR ADDITIONAL DETAILS.
 2. REFER TO DRAINAGE AND UTILITY PLANS FOR ADDITIONAL INFORMATION. CONTRACTOR TO INSTALL DUCT BANK TO AVOID THE STORM SEWERS, WATERLINES, AND WASTEWATER LINES.

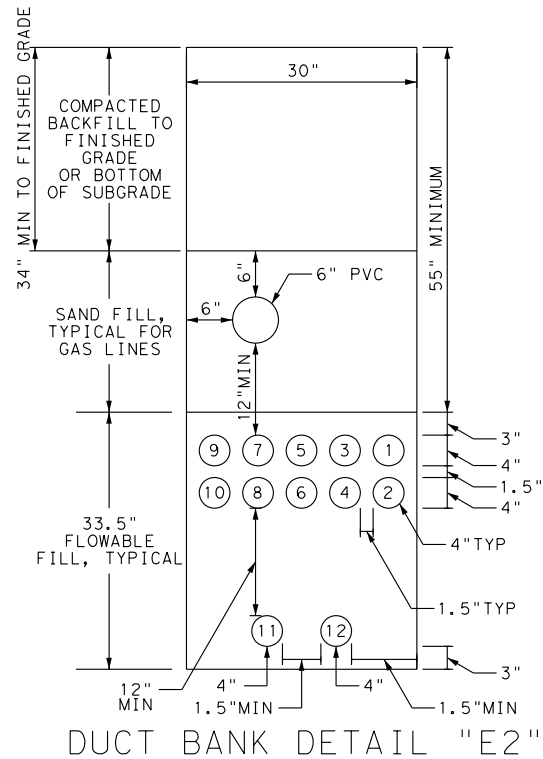

REV. No.	DATE	REVISION	BY

ATKINS TBPE REG. # F-474			
ROUND ROCK TEXAS TRANSPORTATION			
MCNEIL RD EXTENSION DUCT BANK PLACEMENT			
SCALE: 1"=100' SHEET 1 OF 1			
DESIGNED: R. GARCIA		DRAWN: R. GARCIA	
CHECKED: M. SKOVIERA		CHECKED: M. SKOVIERA	
STATE	COUNTY	ROADWAY	SHEET No.
TEXAS	WILLIAMSON	MCNEIL EXTENSION	120C